



# ADDENDUM NUMBER 1

---

LAKE HARTWELL WTP EXPANSION AND OZONE IMPROVEMENTS

FOR

PIONEER RURAL WATER DISTRICT

GMC PROJECT NO. CGRE260010

## 1. Clarifications to the Request for Proposals

- 1.1. Qualified proposers shall submit four (4) copies of proposal documents.
- 1.2. See attached record drawings for the Vertical Turbine (VT) pumps at Raw Water Intake and Finished Water Pump Station.

## 2. Questions

- 2.1. **Question 1:** Would the Selection Committee consider increasing the page limit for the RFP submission, or alternatively, allowing charts, schedules, and similar supporting graphics to be excluded from the overall page count?

**Answer 1:** Schedules and three (3) pages of charts/figures will be excluded from the RFP page count.

## 3. Acknowledgement

- 3.1. Receipt of Addendum No. 1 shall be acknowledged:
  - 3.1.1. Attachment C of the Request for Proposals for Construction Manager At-Risk – Bidder acknowledges receipt of “Addendum No. 1” and date of “May 19, 2026”.

## 4. Attachments

- 4.1. Meeting Minutes from Pre-Proposal Meeting.
- 4.2. Record Drawings for the Raw Water Intake and Finished Water Pump Station.

## 5. Conclusion

- 5.1. This is the end of Addendum Number 1, dated Tuesday, May 19, 2026

*Amy S Hopkins*

Amy Hopkins, PE 43760



# PRE-PROPOSAL MEETING MINUTES

---

LAKE HARTWELL WTP EXPANSION AND OZONE IMPROVEMENTS

FOR

PIONEER RWD

GMC PROJECT NO. CGRE250040

WEDNESDAY APRIL 29<sup>TH</sup>, 2026 @ 2:00 PM

## I. Introductions

## II. Discussion Items

A. Project Overview

B. Request for Proposals Overview

C. Status Update / Proposed Schedule

1. Early Equipment Procurement
2. 60% design – June 2026
3. 90% design – December 2026
4. Construction Start – February 2027
5. Construction Finish – December 2027

D. Funding

1. Phase 1: Privately Funded

E. Key Dates

1. May 14, 2026 - Questions Due
2. May 18, 2026 – Questions will be answered
3. May 21, 2026 – Proposals Due @ 10 AM

a. 5500 W Oak Hwy, Westminster, SC

F. Other Project Discussion Items



# MEETING ATTENDANCE ROSTER

LAKE HARTWELL WTP EXPANSION AND OZONE IMPROVEMENTS

FOR



PIONEER RWD

GMC PROJECT NO. CGRE250040

WEDNESDAY APRIL 29<sup>TH</sup>, 2026 @ 2:00 PM

	<u>NAME (PRINT)</u>	<u>REPRESENTING</u>	<u>EMAIL</u>	<u>PHONE NUMBER</u>
	Amy Hopkins	GMC		803.315.3950
1.	Andrew Merritt	State Utility	amerritt@sucontractors.com	704.201.9282
2.	LARRY EBERHART	Reeves Young	leberhart@reevesyoung.com	864 906 7599
3.	MONICA PINEDA	REEVES YOUNG	mpineda@reevesyoung.com	803 480 5608
4.	Carsen Landreth	Harper GC	Carsen.Landreth@harpergc.com	864 760 7635
5.	Justin Jones	Harper GC	justinj@harpergc.com	843 637 7815
6.	JAMES McMULLAN	HARPER GC	JMCMULLAN@HARPERGC.COM	864-617-0259
7.	MATT LANDING	MB KATH	MLANDING@MBKATH.COM	839-292-2084
8.	Jeff Caffery	Cove Utility	Jeff@coveutility.com	864-505-5017
9.	Johnny Mattison	Labor finders	estimating@morgerl.com	864-249-8640
10.	Heather Bryant	Pioneer		EXT 461
11.	Terry Pruitt	Pioneer		
12.	Gary Harper	Pioneer		
13.				
14.				
15.				
16.				
17.				
18.				

COPYRIGHT © 2015 BY DESIGN SOUTH PROFESSIONALS, INC. ALL RIGHTS RESERVED. THIS DOCUMENT IS THE PROPERTY OF DESIGN SOUTH PROFESSIONALS, INC. IT IS TO BE USED ONLY FOR THE SPECIFIC PROJECT IDENTIFIED OR REFERRED TO HEREIN AND IS NOT TO BE USED ON OTHER PROJECTS OR EXTENSIONS TO THIS PROJECT, IN WHOLE OR PART, EXCEPT BY WRITTEN AGREEMENT AND COMPENSATION TO DESIGN SOUTH PROFESSIONALS, INC.

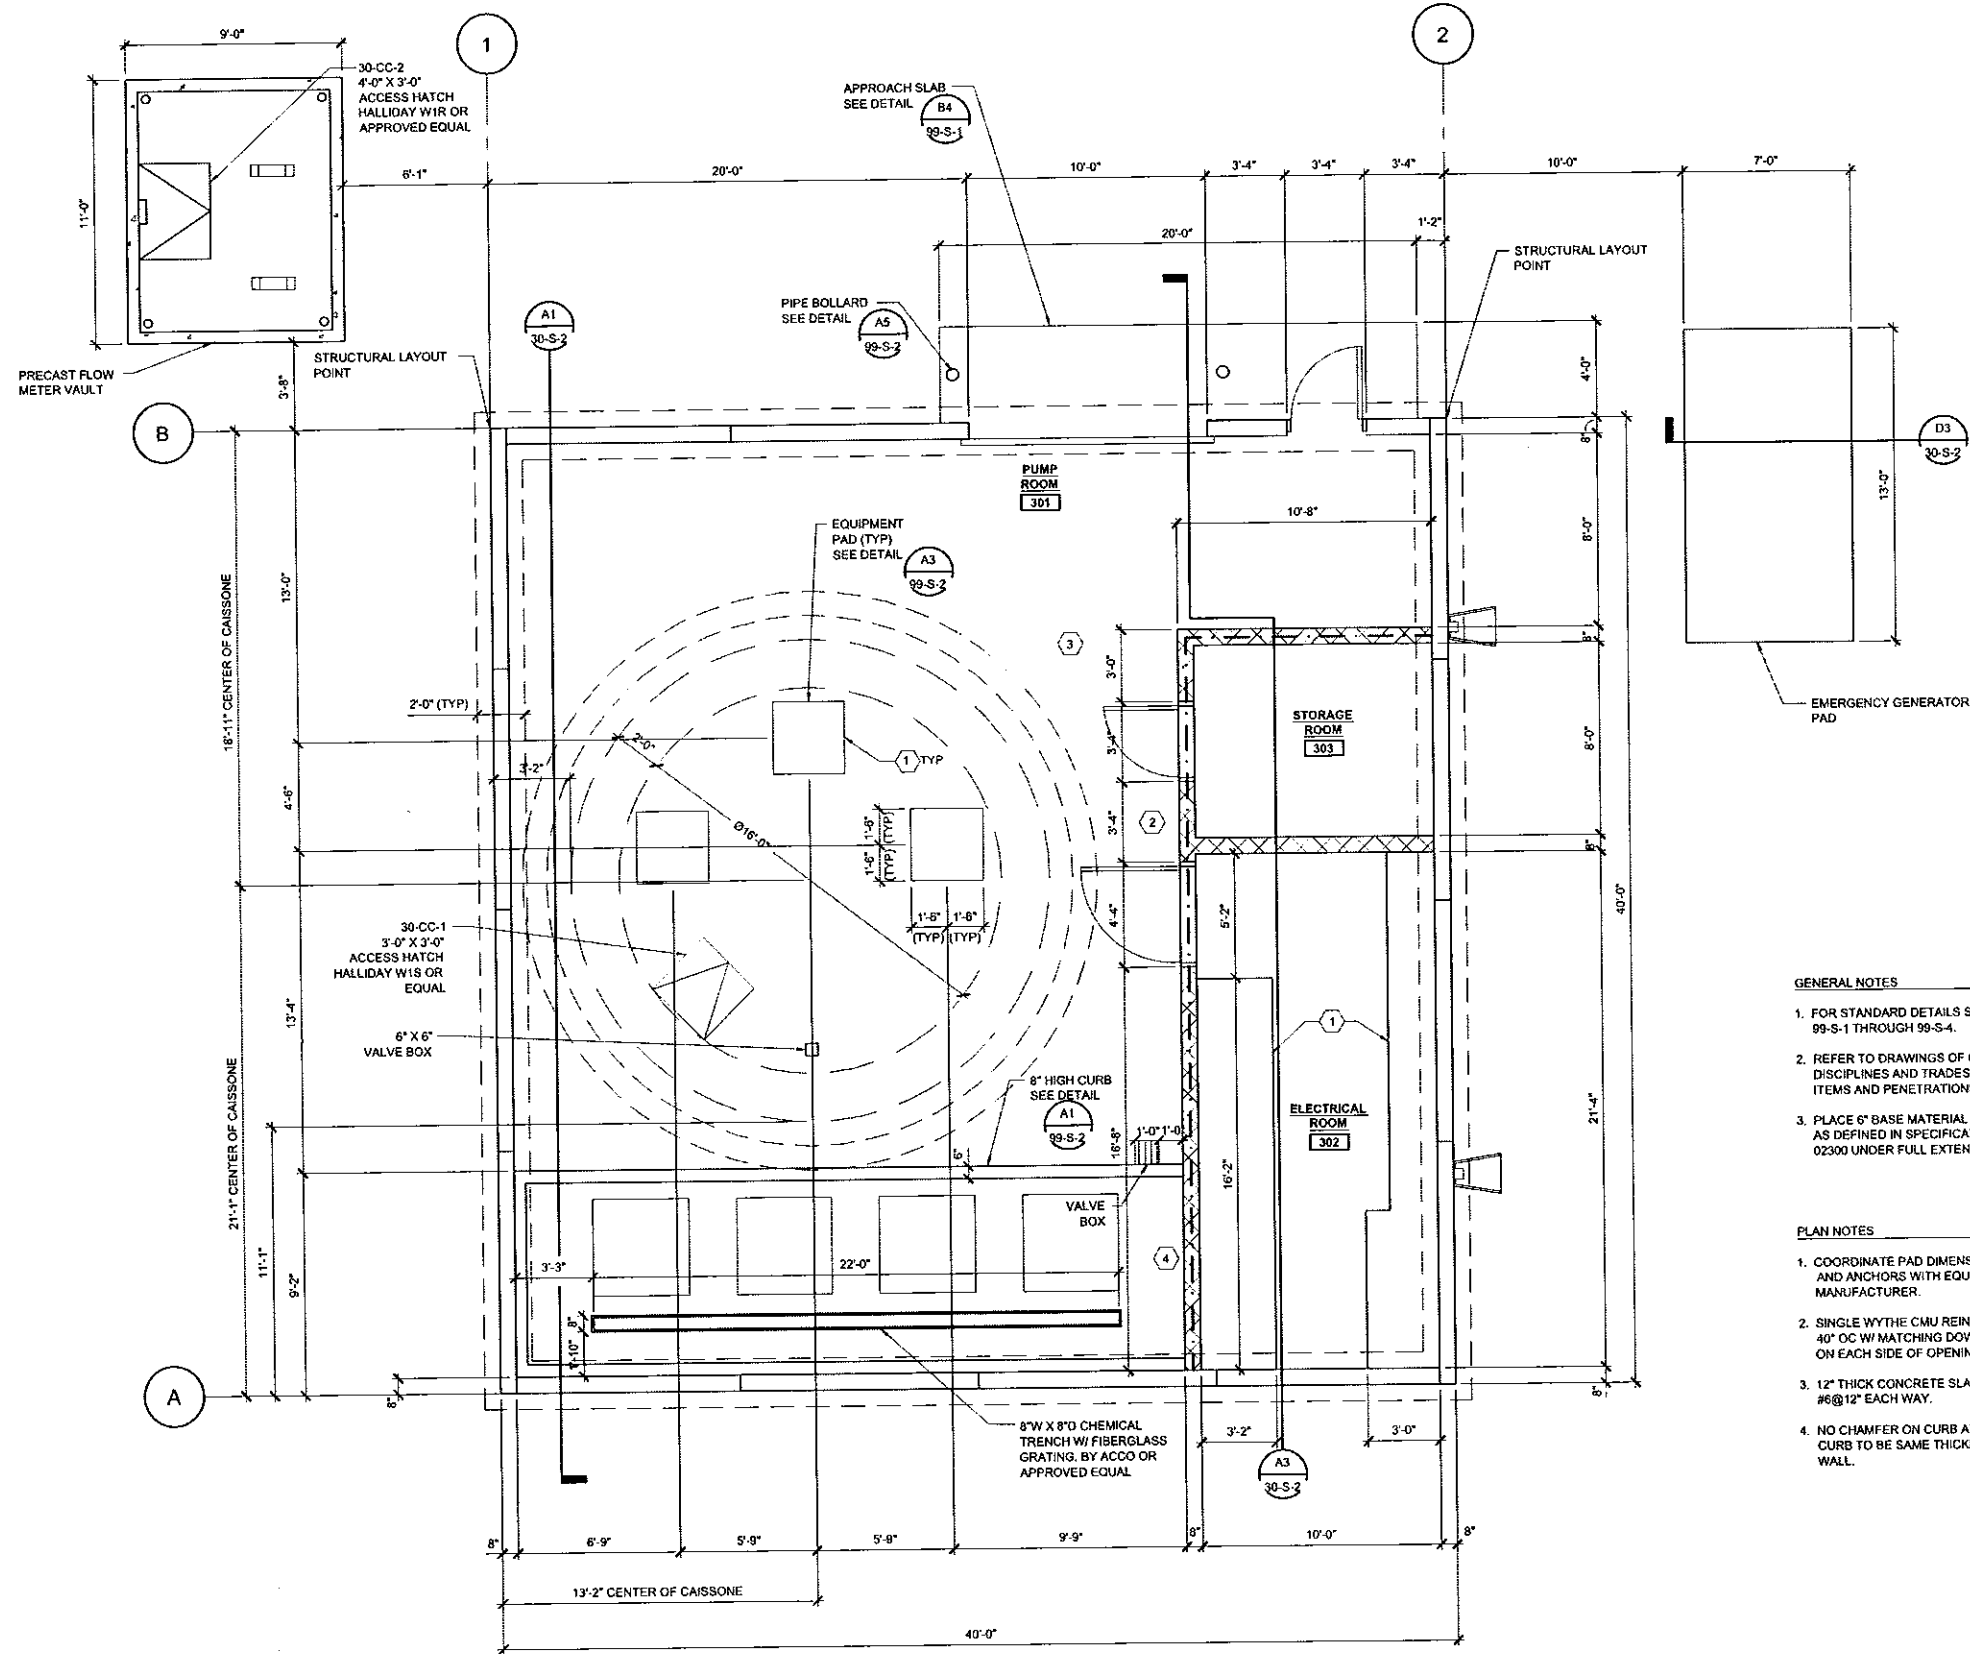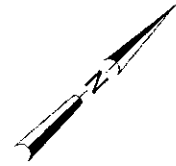

- GENERAL NOTES**
- FOR STANDARD DETAILS SEE SHEETS 99-S-1 THROUGH 99-S-4.
  - REFER TO DRAWINGS OF OTHER DISCIPLINES AND TRADES FOR EMBEDDED ITEMS AND PENETRATIONS NOT SHOWN.
  - PLACE 6" BASE MATERIAL OR 2" MUD SLAB AS DEFINED IN SPECIFICATION SECTION 02300 UNDER FULL EXTENT OF STRUCTURE.

- PLAN NOTES**
- COORDINATE PAD DIMENSIONS, OPENINGS, AND ANCHORS WITH EQUIPMENT MANUFACTURER.
  - SINGLE WYTHE CMU REINFORCED W/ #4 @ 40" OC W/ MATCHING DOWELS ON EACH SIDE OF OPENINGS
  - 12" THICK CONCRETE SLAB REINFORCED W/ #6@12" EACH WAY.
  - NO CHAMFER ON CURB AT BLOCK WALL. CURB TO BE SAME THICKNESS AS BLOCK WALL.

NO.	A	07/31/15	ISSUED FOR AGENCY APPROVAL	DESCRIPTION	BY	CHKD	DRWN	NO.	DATE	DESCRIPTION		
<table border="1" style="width: 100%; border-collapse: collapse;"> <tr> <td style="width: 50%; text-align: center;">LAKE HARTWELL WATER TREATMENT PLANT</td> <td style="width: 50%; text-align: center;">RAW WATER PUMP STATION PLAN</td> </tr> </table>											LAKE HARTWELL WATER TREATMENT PLANT	RAW WATER PUMP STATION PLAN
LAKE HARTWELL WATER TREATMENT PLANT	RAW WATER PUMP STATION PLAN											
<b>PIONEER</b> EST. 1985 RURAL WATER DISTRICT												
<b>DESIGN SOUTH PROFESSIONALS, INC.</b> engineers architects planners THREE LINWA BOULEVARD ANDERSON, SOUTH CAROLINA, 29621 (864) 226-6111												
CERTIFICATE OF PROFESSIONAL ENGINEER DONALD J. HARTWELL NO. 21190 EXPIRES 7-31-15												
STATE OF NORTH CAROLINA PROFESSIONAL ENGINEER												



A1 PLAN  
1/4" = 1'-0"

PENDING AGENCY REVIEW - RELEASED FOR CONSTRUCTION

SHEET NO.  
**30-S-1**

DESIGNED BY DJP	CHECKED BY JAG
DRAWN BY RBS	PROJ. NO. 0743
DATE 04/06/15	FILE NO. 30-S-1

COPYRIGHT © 2015, BY DESIGN SOUTH PROFESSIONALS, INC. ALL RIGHTS RESERVED. THIS DOCUMENT IS THE PROPERTY OF DESIGN SOUTH PROFESSIONALS, INC. IT IS TO BE USED ONLY FOR THE SPECIFIC PROJECT IDENTIFIED OR REFERRED TO HEREIN AND IS NOT TO BE USED ON OTHER PROJECTS OR EXTENSIONS TO THIS PROJECT, IN WHOLE OR PART, EXCEPT BY WRITTEN AGREEMENT AND COMPENSATION TO DESIGN SOUTH PROFESSIONALS, INC.

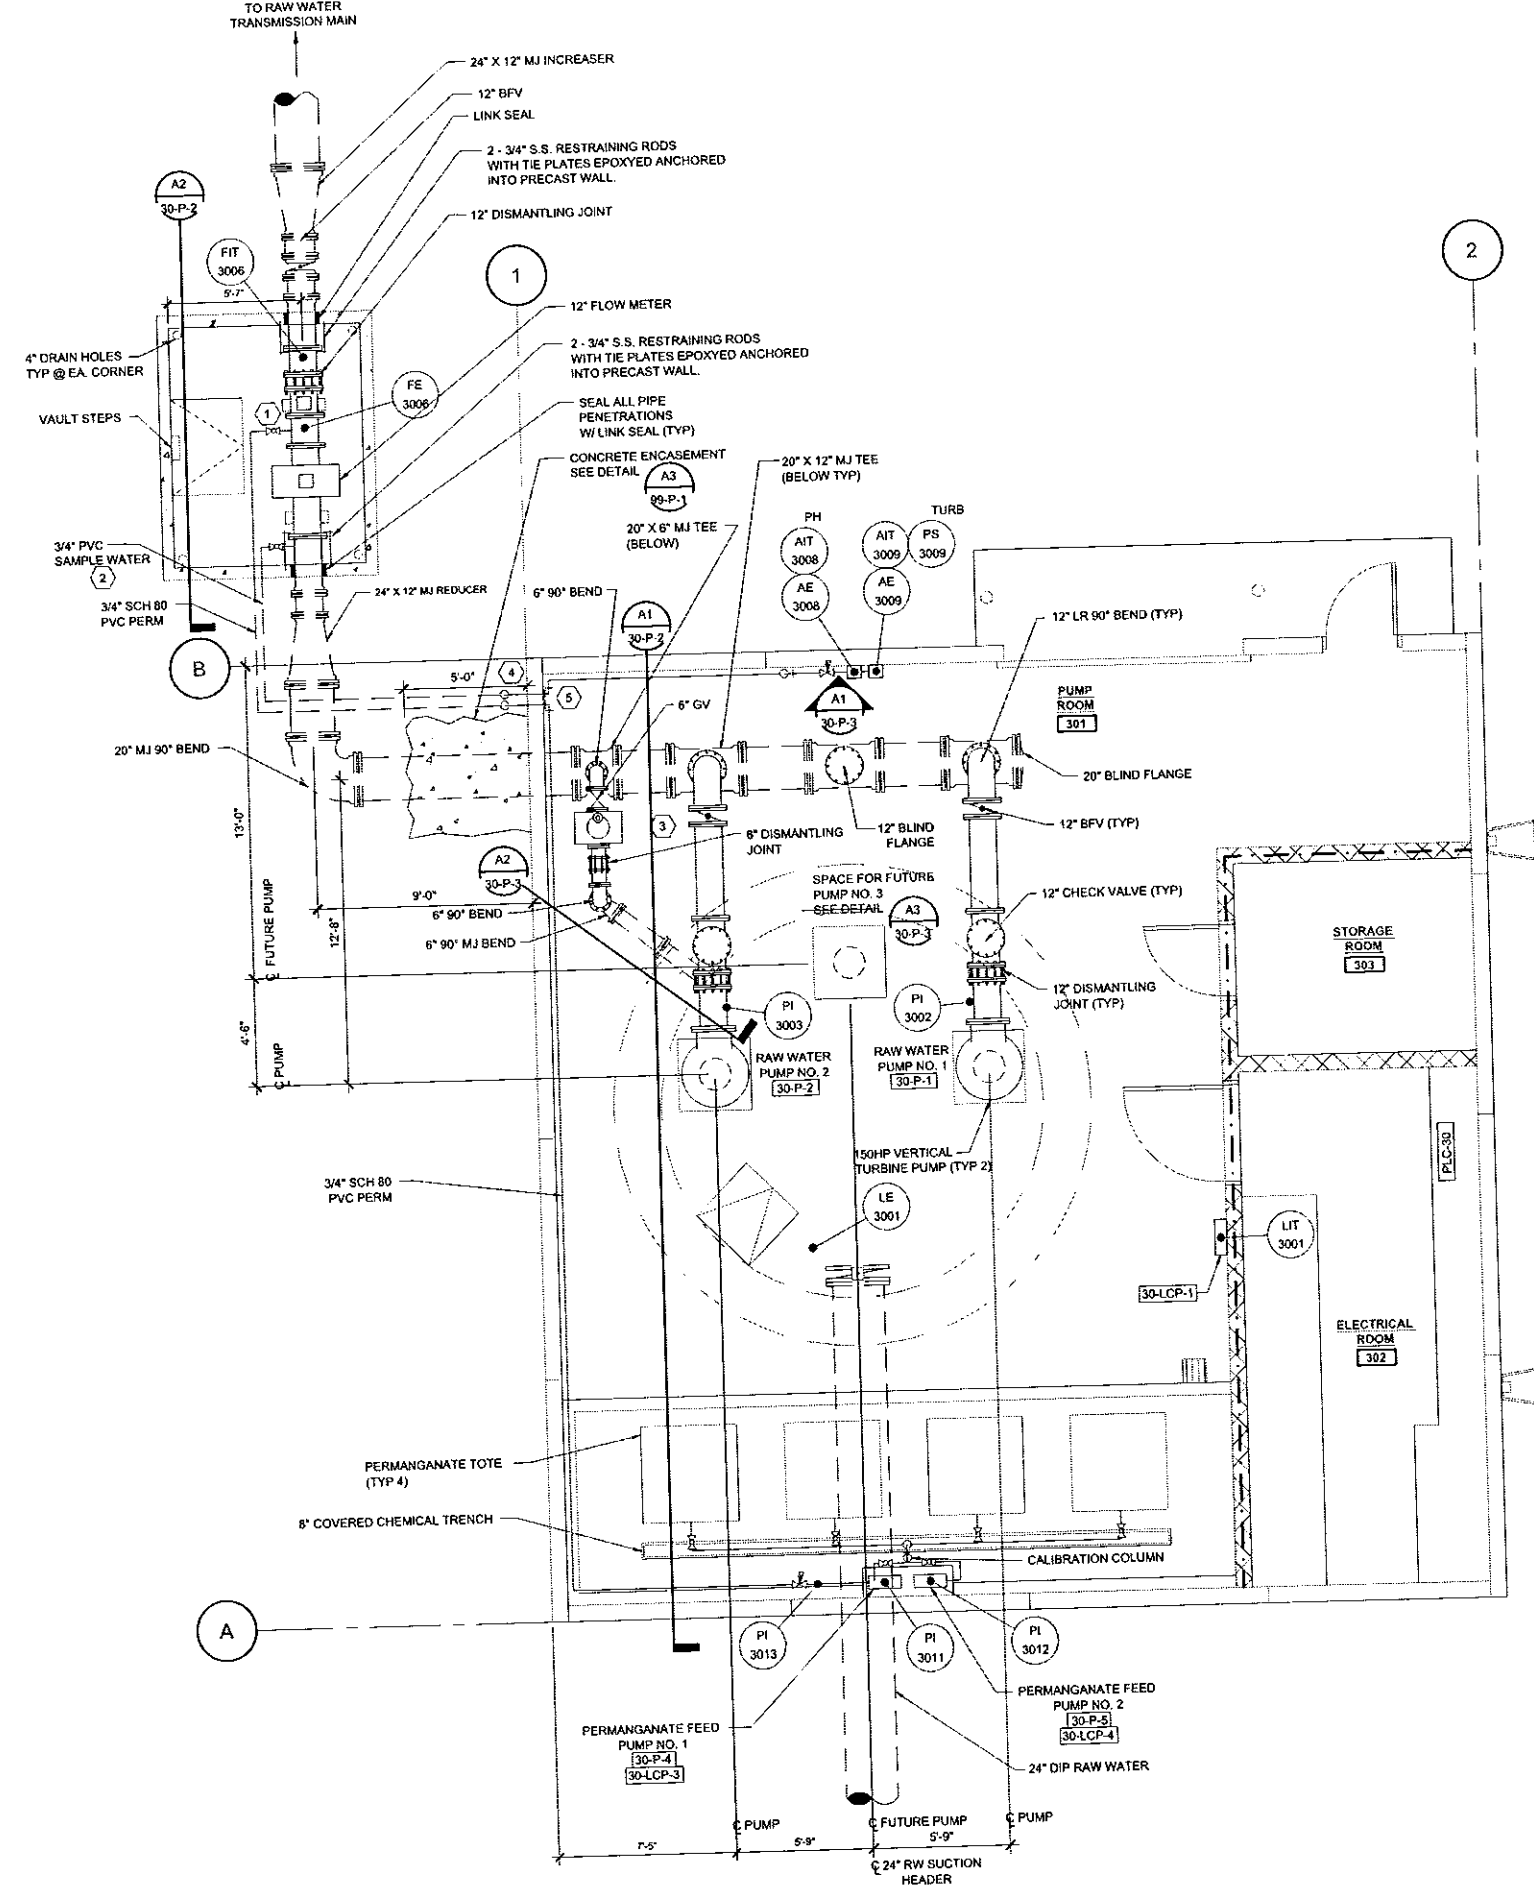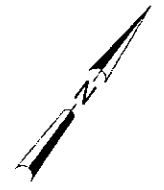

- PLAN NOTES:**
1. PROVIDE 3/4" RETRACTABLE INJECTION QUILL WITH CORPORATION STOP FOR PERMANGANATE CHEMICAL FEED PIPING.
  2. PROVIDE 3/4" CORPORATION STOP FOR SAMPLE WATER PIPING.
  3. GA INDUSTRIES 6" 6700-D GLOBE BODY SURGE RELIEF VALVE OR APPROVED EQUAL.
  4. INSULATE ALL EXTERIOR CHEMICAL PIPING, SMALL PROCESS PIPING AND WATER PIPING.
  5. SEE DETAIL A1/89-P-1 FOR WALL PENETRATIONS.

**A1 PLAN**  
1/4" = 1'

PENDING AGENCY REVIEW - RELEASED FOR CONSTRUCTION

NO.	DATE	ISSUED FOR AGENCY APPROVAL	DESCRIPTION	BY	CHKD	DRWN	NO.	DATE	REVISIONS
A	07/31/15								


**LAKE HARTWELL  
WATER TREATMENT PLANT**

**RAW WATER PUMP STATION  
PLAN**


**DESIGN SOUTH  
PROFESSIONALS, INC.**  
engineers architects  
planners

THREE LINWA BOULEVARD  
ANDERSON, SOUTH CAROLINA 29621  
(864) 226-6111


COPYRIGHT © 2015 BY DESIGN SOUTH PROFESSIONALS, INC. ALL RIGHTS RESERVED. THIS DOCUMENT IS THE PROPERTY OF DESIGN SOUTH PROFESSIONALS, INC. IT IS TO BE USED ONLY FOR THE SPECIFIC PROJECT IDENTIFIED OR REFERRED TO HEREIN AND IS NOT TO BE USED ON OTHER PROJECTS OR EXTENSIONS TO THIS PROJECT, IN WHOLE OR PART, EXCEPT BY WRITTEN AGREEMENT AND COMPENSATION TO DESIGN SOUTH PROFESSIONALS, INC.

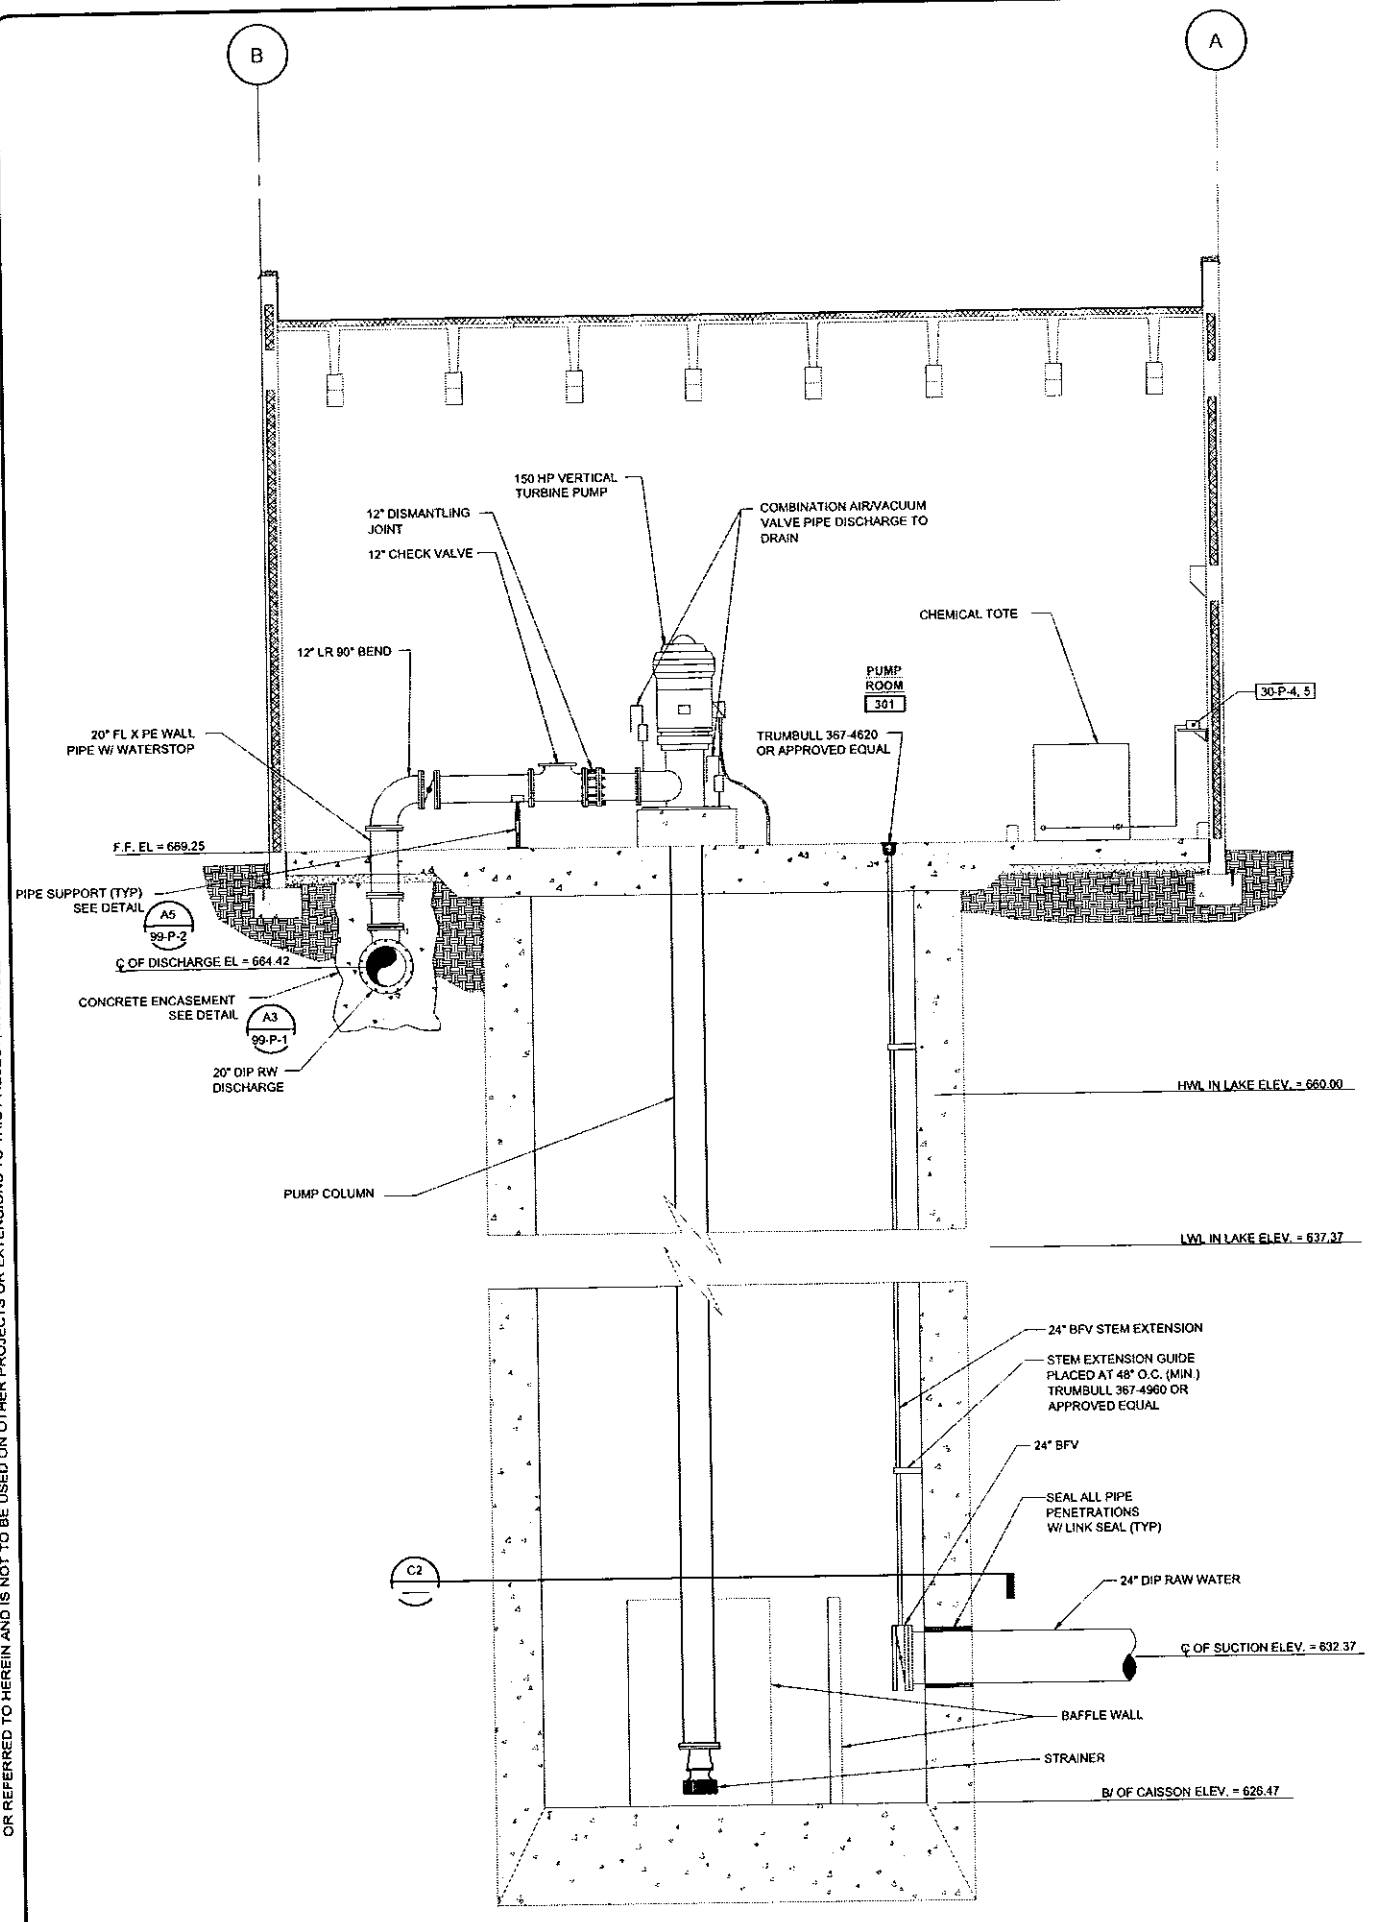

**A1 SECTION**  
1/4" = 1'-0"

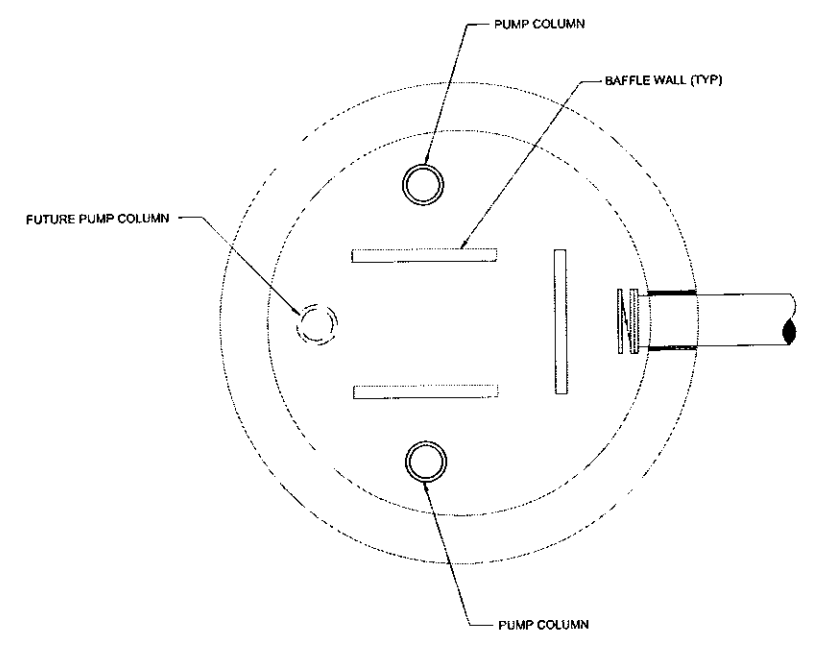


**C2 SECTION**  
1/4" = 1'-0"

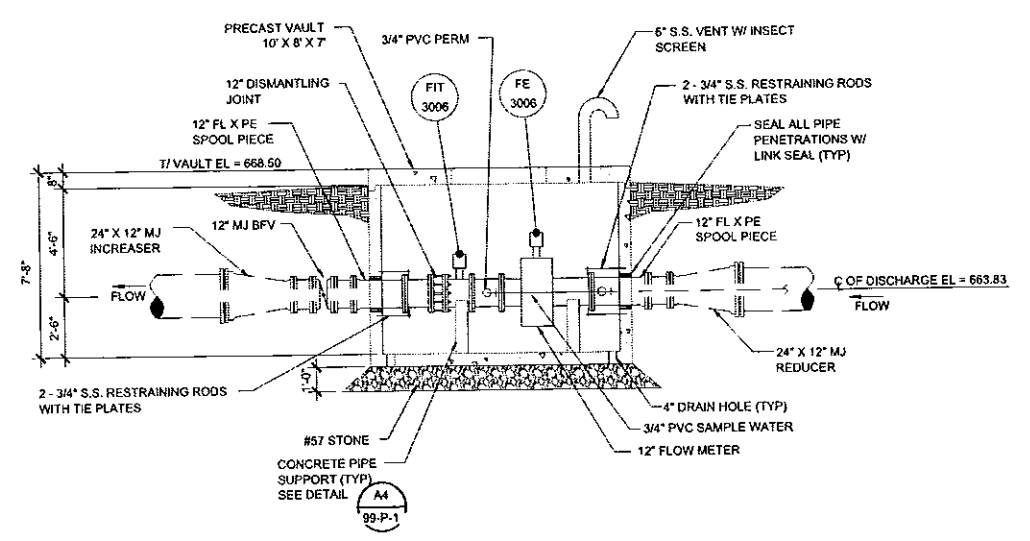



**A2 RAW WATER FLOW METER VAULT**  
1/4" = 1'-0"

PENDING AGENCY REVIEW - RELEASED FOR CONSTRUCTION

NO.	DATE	ISSUED FOR AGENCY APPROVAL	DESCRIPTION	RBS	JAG	DJP	BY	CHKD	DRWN	NO.	DATE	DESCRIPTION	REVISIONS
A	07/31/15												

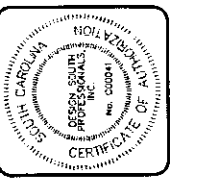

**DESIGN SOUTH PROFESSIONALS, INC.**  
 engineers architects planners  
 THREE LINWA BOULEVARD  
 ANDERSON, SOUTH CAROLINA 29621  
 (864) 226-6111

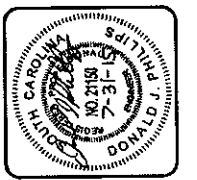
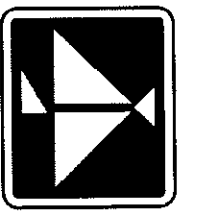


LAKE HARTWELL  
 WATER TREATMENT PLANT  
 RAW WATER PUMP STATION  
 SECTIONS AND DETAILS

DESIGNED BY DJP	CHECKED BY JAG
DRAWN BY RBS	PROJ. NO. 0743
DATE 04/08/15	FILE NO. 30-P-2

SHEET NO.  
**30-P-2**

COPYRIGHT © 2015, BY DESIGN SOUTH PROFESSIONALS, INC. ALL RIGHTS RESERVED. THIS DOCUMENT IS THE PROPERTY OF DESIGN SOUTH PROFESSIONALS, INC. IT IS TO BE USED ONLY FOR THE SPECIFIC PROJECT IDENTIFIED OR REFERRED TO HEREIN AND IS NOT TO BE USED ON OTHER PROJECTS OR EXTENSIONS TO THIS PROJECT, IN WHOLE OR PART, EXCEPT BY WRITTEN AGREEMENT AND COMPENSATION TO DESIGN SOUTH PROFESSIONALS, INC.

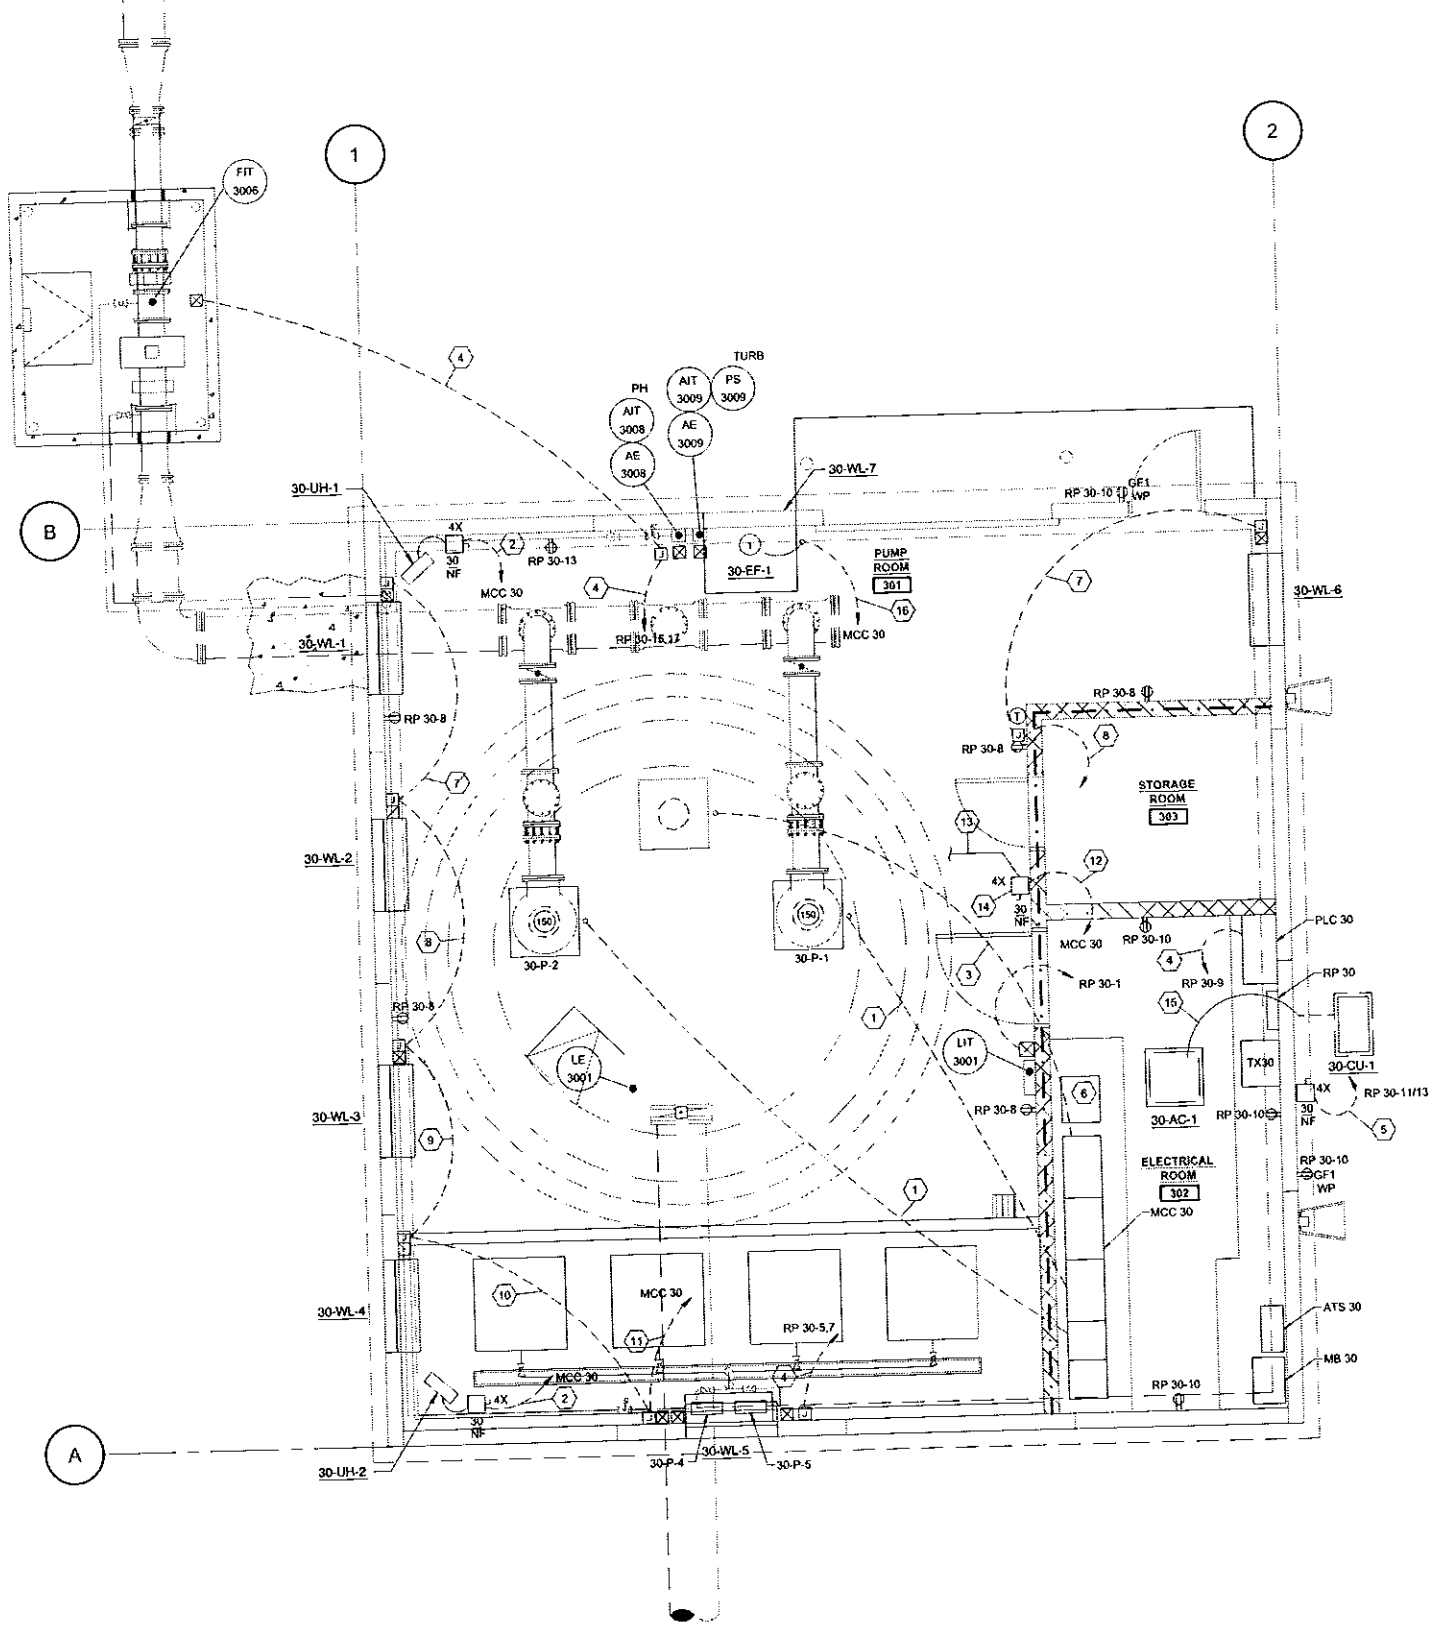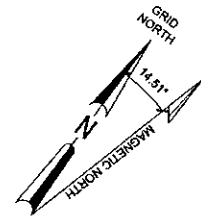

- PLAN NOTES:
1. VFD CABLE (3#40 WITH GND), 2#14-3" C.
  2. 3#12, 1#12G-3/4" C.
  3. 3" E.C.
  4. 2#12, 1#12G-3/4" C.
  5. 2#8, 1#10G-1" C. (208V)
  6. ACTIVE HARMONIC FILTER
  7. 2#12, 1#12G, 2#14-2" C.
  8. 2#12, 1#12G, 4#14-3/4" C.
  9. 2#12, 1#12G, 6#14-1" C.
  10. 2#12, 1#12G, 6#14-1" C.
  11. 2#12, 1#12G, 10#14-1" C.
  12. 3#10, 1#10G-3/4" C.
  13. 4#12, 1#12G-3/4" C.
  14. LOCATE FOR BRIDGE CRANE. PROVIDE WIRING AS DIRECTED BY SUPPLIER.
  15. 1" CONDUIT FOR INTERCONNECTING WIRING. COORDINATE WITH SUPPLIER.
  16. 6#12, 1#12G-3/4" C.

A1 POWER PLAN  
1/4" = 1'

PENDING AGENCY REVIEW - RELEASED FOR CONSTRUCTION

**HOWARD ENGINEERING**  
ELECTRICAL • CONTROLS • AUTOMATION  
MARIETTA, SOUTH CAROLINA  
(864) - 936 0400

NO.	DATE	ISSUED FOR AGENCY APPROVAL	DESCRIPTION	BY	CHK'D	LDR
A	06/19/15					

LAKE HARTWELL WATER TREATMENT PLANT	PIONEER RURAL WATER DISTRICT
RAW WATER PUMP STATION POWER PLAN	




DESIGNED BY ATH	CHECKED BY ATH
DRAWN BY HNW	PROJ. NO. 0743
DATE 06/05/15	FILE NO. 30-E-1

SHEET NO.  
**30-E-1**





**DESIGN SOUTH PROFESSIONALS, INC.**  
engineers architects planners  
THREE LINWA BOULEVARD  
ANDERSON, SOUTH CAROLINA 29621  
(864) 226 - 6111

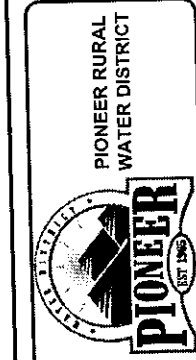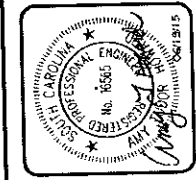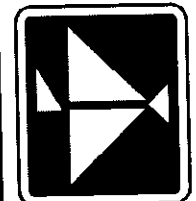

COPYRIGHT © 2015, BY DESIGN SOUTH PROFESSIONALS, INC. ALL RIGHTS RESERVED. THIS DOCUMENT IS THE PROPERTY OF DESIGN SOUTH PROFESSIONALS, INC. IT IS TO BE USED ONLY FOR THE SPECIFIC PROJECT IDENTIFIED OR REFERRED TO HEREIN AND IS NOT TO BE USED ON OTHER PROJECTS OR EXTENSIONS TO THIS PROJECT, IN WHOLE OR PART, EXCEPT BY WRITTEN AGREEMENT AND COMPENSATION TO DESIGN SOUTH PROFESSIONALS, INC.

- PLAN NOTES:**
1. PROVIDE 3/4" CORPORATION STOP FOR SAMPLE WATER PIPING.
  2. PROVIDE 1" PVC DRAIN FROM CL2 ANALYZER TO TRENCH DRAIN.
  3. PROVIDE 3/4" PRV AND ROTOMETER TO PROVIDE PROPER FLOW AND PRESSURE TO AIT=7506

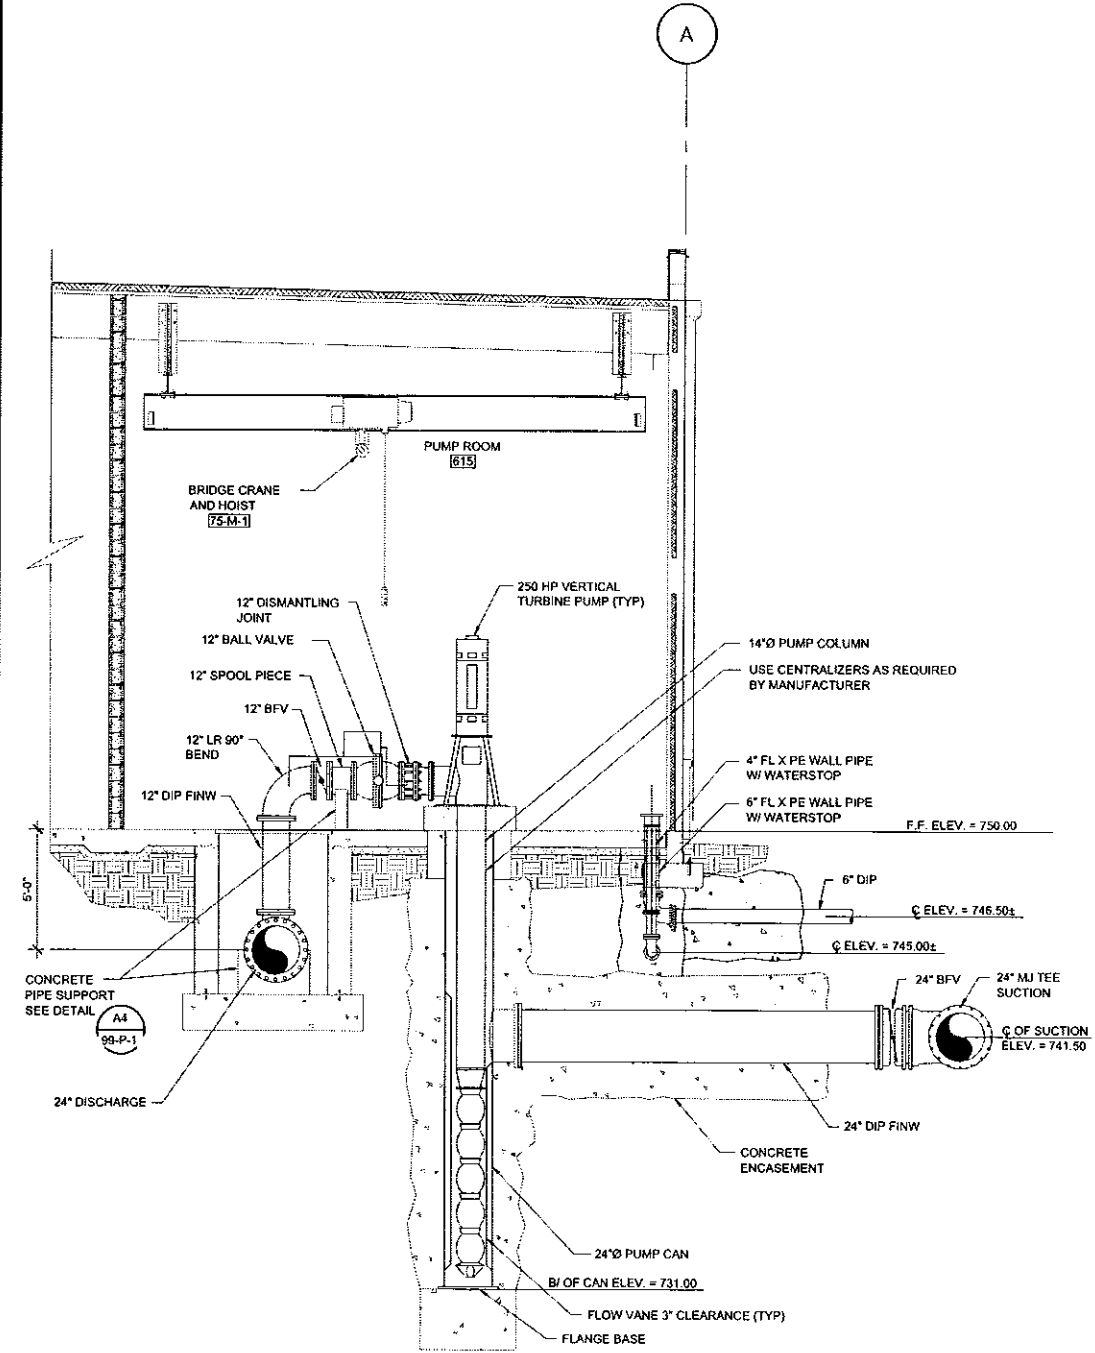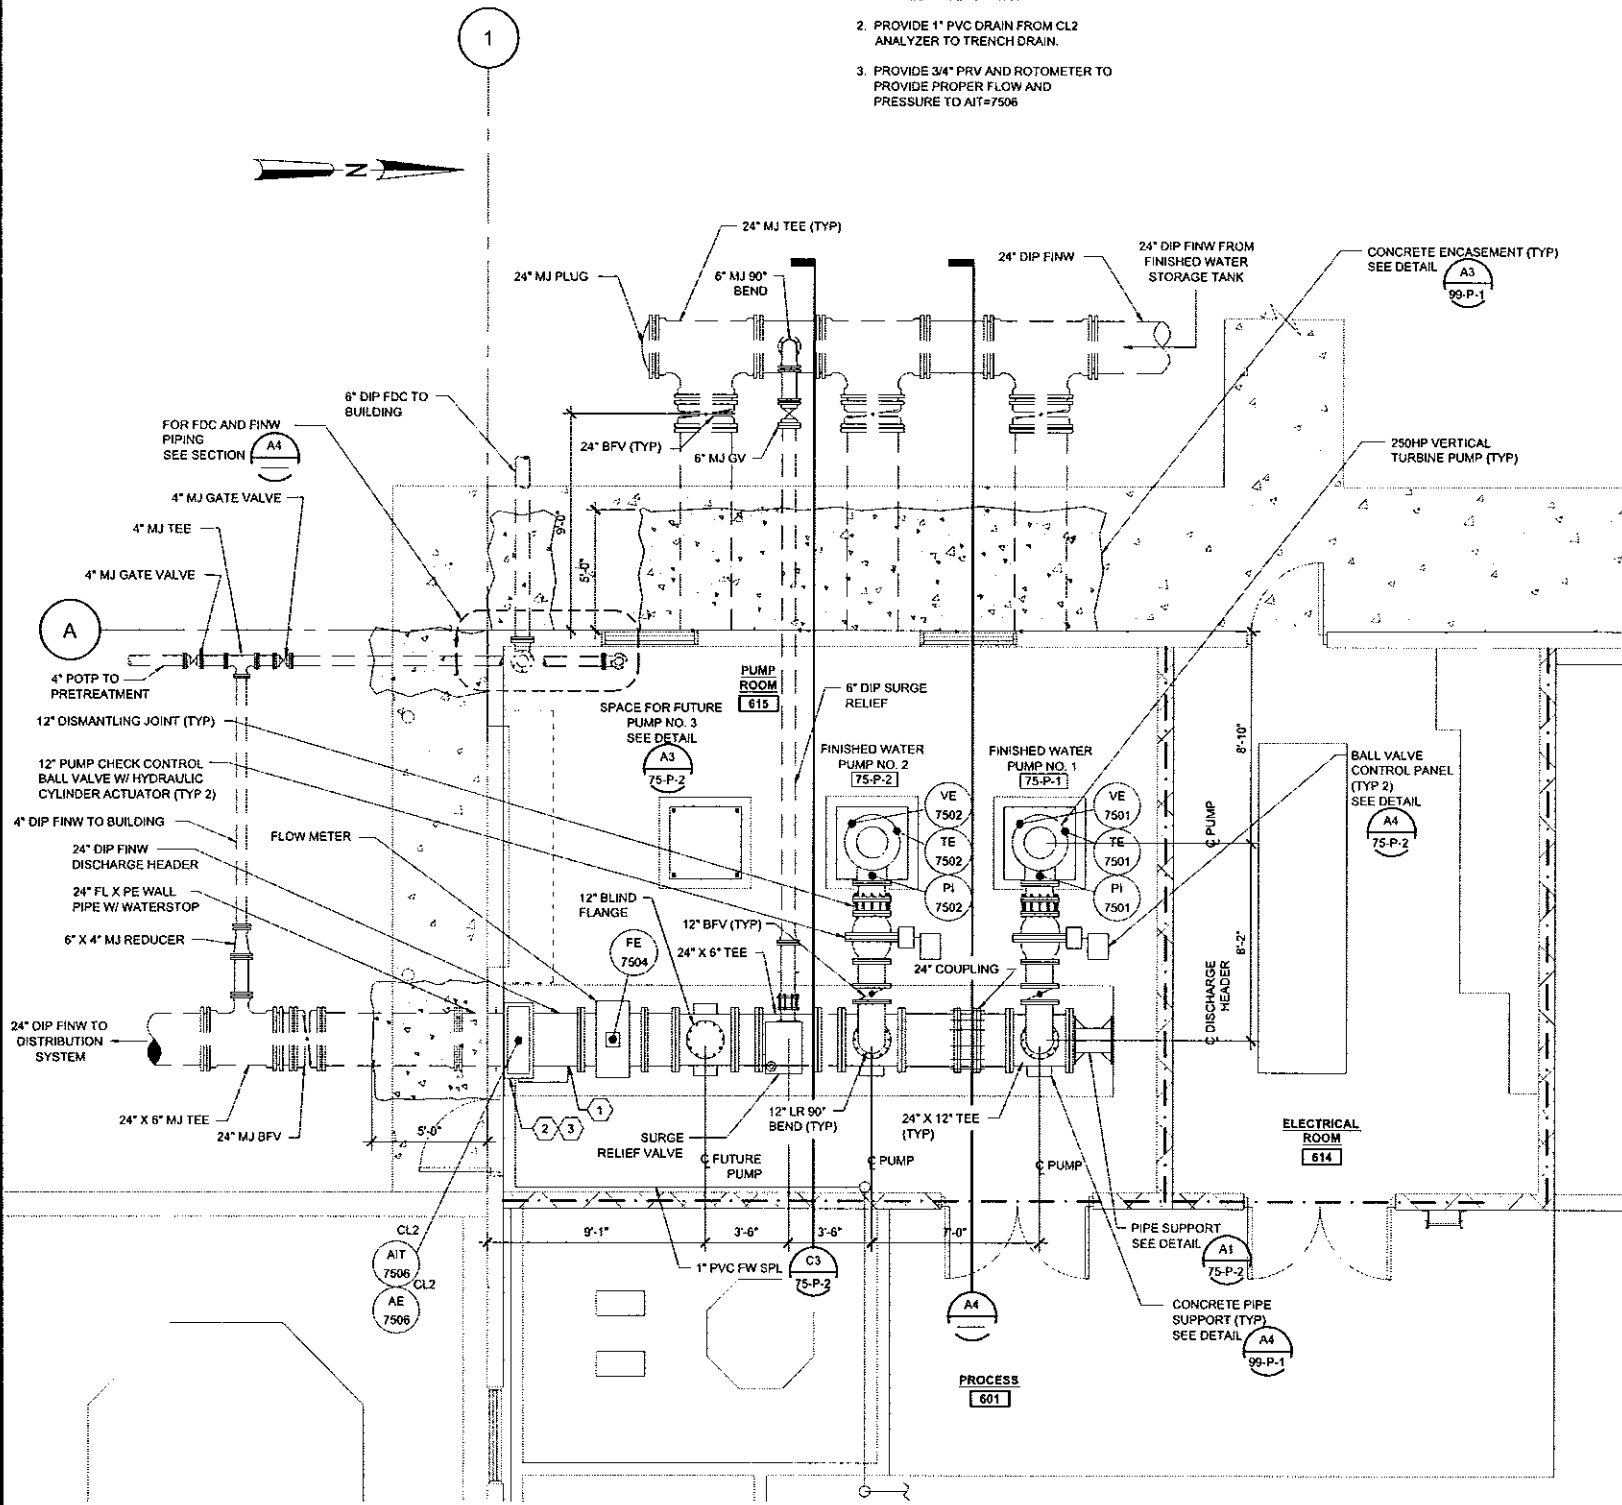

**A1 PLAN**  
1/4" = 1'-0"

**A4 SECTION**  
1/4" = 1'-0"

PENDING AGENCY REVIEW - RELEASED FOR CONSTRUCTION

NO.	DATE	ISSUED FOR AGENCY APPROVAL	DJP	JAG	RBS	NO.	DATE	DESCRIPTION
A	07/31/15							

NO.	DATE	BY	CHKD	DRWN	NO.	DATE	DESCRIPTION

**DESIGN SOUTH PROFESSIONALS, INC.**  
engineers architects planners  
THREE LINWA BOULEVARD  
ANDERSON, SOUTH CAROLINA 29621  
(864) 226-6111

**PIONEER WATER DISTRICT**  
EST. 1965



LAKE HARTWELL WATER TREATMENT PLANT

FINISHED WATER PUMPING PLAN AND SECTION


DESIGNED BY	CHECKED BY
DJP	JAG
DRAWN BY	PRJ. NO.
RBS	0743
DATE	FILE NO.
04/08/15	75-P-1

SHEET NO.
<b>75-P-1</b>

COPYRIGHT © 2015, BY DESIGN SOUTH PROFESSIONALS, INC. ALL RIGHTS RESERVED. THIS DOCUMENT IS THE PROPERTY OF DESIGN SOUTH PROFESSIONALS, INC. IT IS TO BE USED ONLY FOR THE SPECIFIC PROJECT IDENTIFIED OR REFERRED TO HEREIN AND IS NOT TO BE USED ON OTHER PROJECTS OR EXTENSIONS TO THIS PROJECT, IN WHOLE OR PART, EXCEPT BY WRITTEN AGREEMENT AND COMPENSATION TO DESIGN SOUTH PROFESSIONALS, INC.

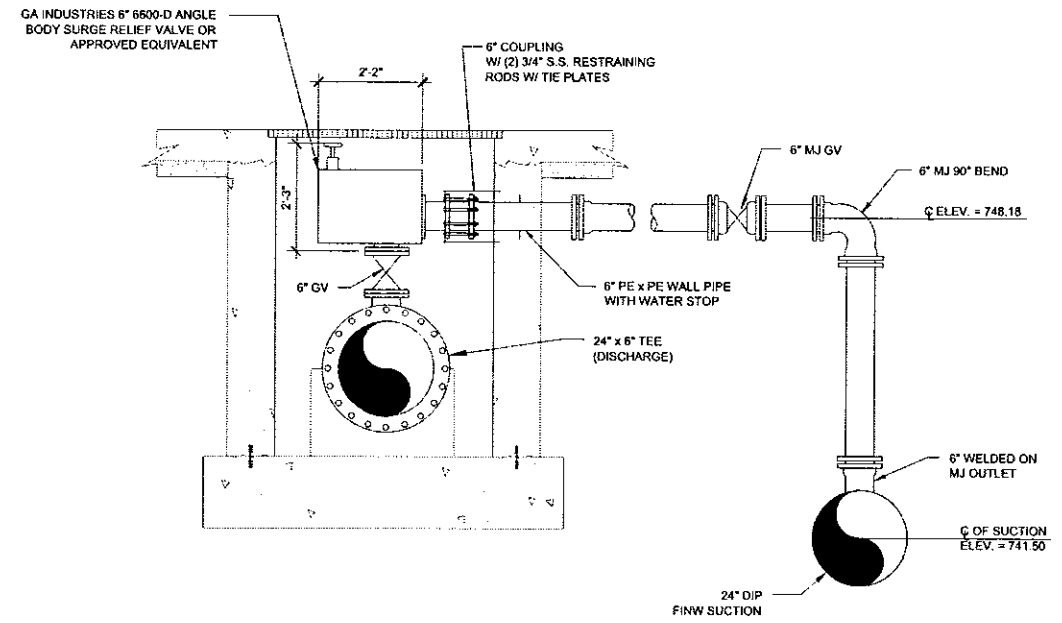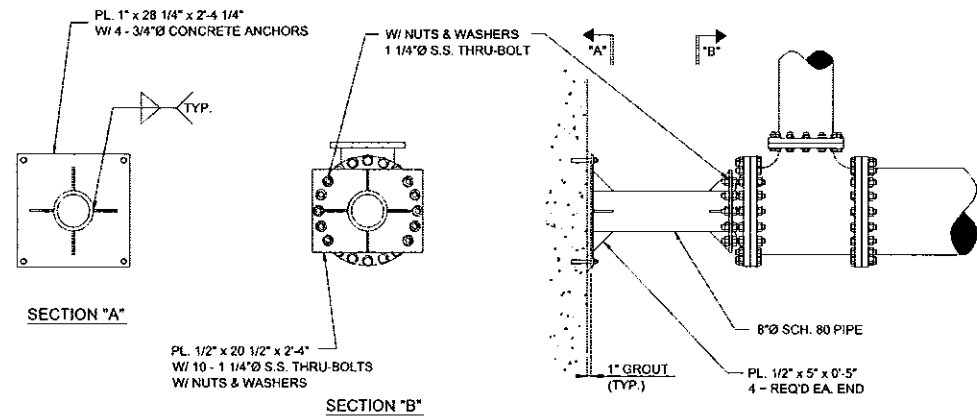

C3 SECTION  
1/2" = 1'-0"

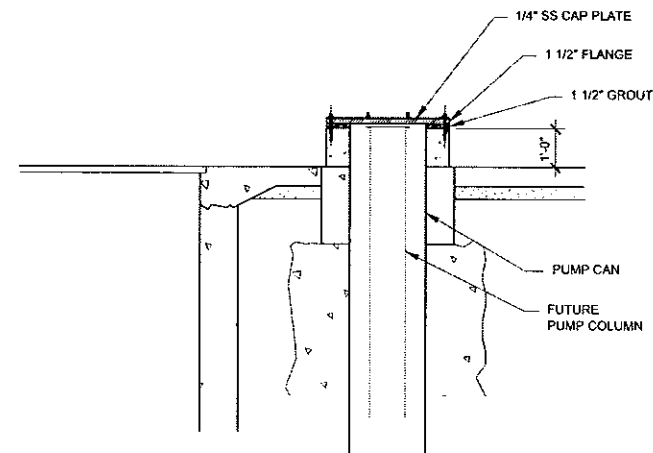

A3 DETAIL  
NTS

A1 DETAIL  
1/2" = 1'-0"

NO.	DATE	ISSUED FOR AGENCY APPROVAL	DJP	JAG	RES	NO.	DATE	DESCRIPTION	BY	CH'D	NO.	DATE	DESCRIPTION	BY	CH'D	NO.	DATE	DESCRIPTION
A	07/01/15	ISSUED FOR AGENCY APPROVAL	DJP	JAG	RBS													

LAKE HARTWELL  
WATER TREATMENT PLANT


 
FINISHED WATER PUMPING  
DETAILS

PIONEER  
WATER DISTRICT

DESIGN SOUTH  
PROFESSIONALS, INC.  
engineers architects planners

THREE LINWA BOULEVARD  
ANDERSON, SOUTH CAROLINA, 29621  
(864) 226 - 6111

COPYRIGHT © 2015, BY DESIGN SOUTH PROFESSIONALS, INC. ALL RIGHTS RESERVED. THIS DOCUMENT IS THE PROPERTY OF DESIGN SOUTH PROFESSIONALS, INC. IT IS TO BE USED ONLY FOR THE SPECIFIC PROJECT IDENTIFIED OR REFERRED TO HEREIN AND IS NOT TO BE USED ON OTHER PROJECTS OR EXTENSIONS TO THIS PROJECT. IN WHOLE OR PART, EXCEPT BY WRITTEN AGREEMENT AND COMPENSATION TO DESIGN SOUTH PROFESSIONALS, INC.

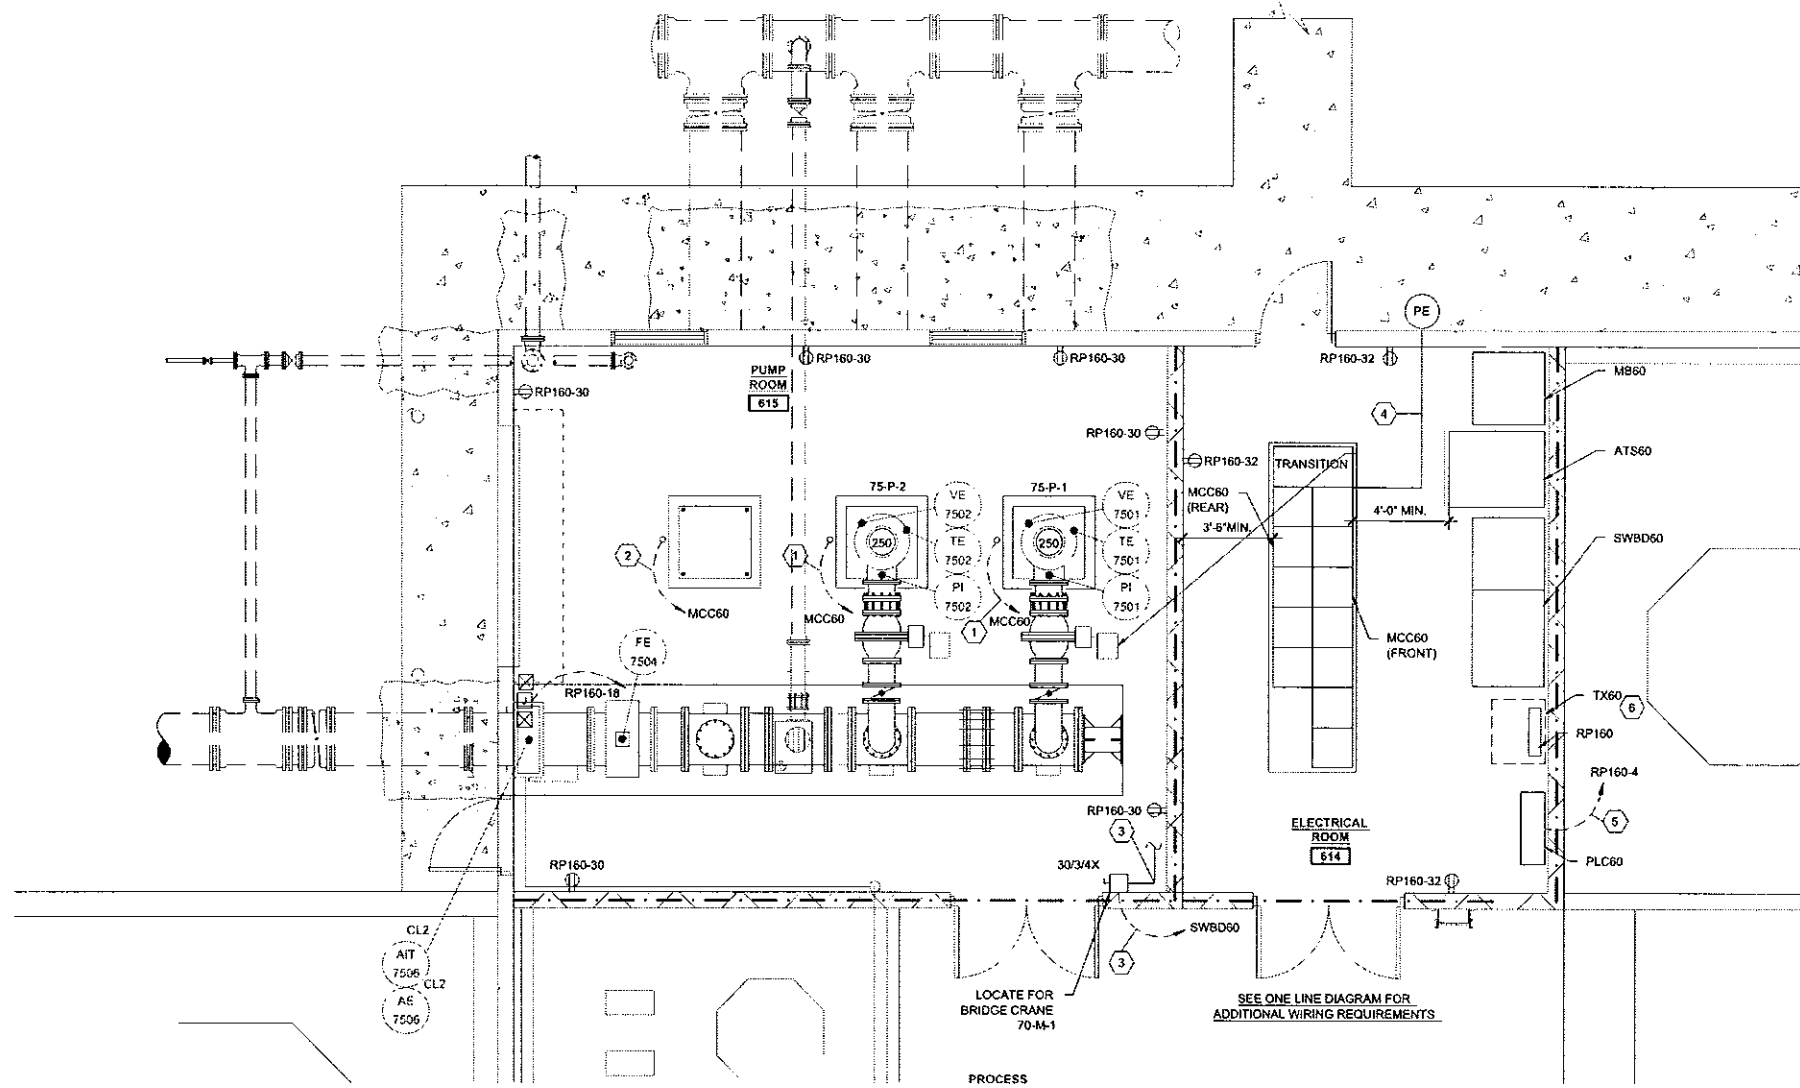



- NOTES:
1. 3/500KCM, 1#2G., 2#14-3/4".
  2. 3" EC
  3. 3#10, 1#10G., 3/4" C.
  4. 2#14-3/4" C.
  5. 2#12, 1#12G., 3/4" C.
  6. INSTALL IN MEZZANINE AREA ABOVE ELECTRICAL ROOM

**HOWARD ENGINEERING**  
 ELECTRICAL • CONTROLS • AUTOMATION  
 MARIETTA, SOUTH CAROLINA  
 (864) - 936 0110


NO.	DATE	ISSUED FOR AGENCY APPROVAL	DESCRIPTION	BY	CHKD	DRWN	NO.	DATE	DESCRIPTION	BY	CHKD	DRWN
A	08/18/15	ISSUED FOR AGENCY APPROVAL	DESIGN									



**DESIGN SOUTH PROFESSIONALS, INC.**  
 engineers architects planners  
 THREE LINNA BOULEVARD  
 ANDERSON, SOUTH CAROLINA, 29621  
 (864) 226 - 6111

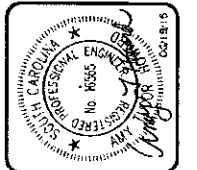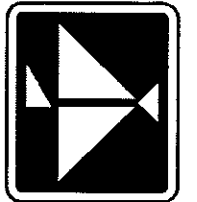

**PIONEER RURAL WATER DISTRICT**

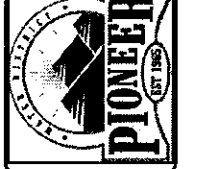

**LAKE HARTWELL WATER TREATMENT PLANT**  
 FINISHED WATER PUMP ROOM AND ELECTRICAL ROOM POWER PLAN

DESIGNED BY	CHECKED BY
ATH	JAG
DRAWN BY	PROJ. NO.
HNW	0743
DATE	FILE NO.
06/05/15	75-P-1

SHEET NO.  
**75-E-1**

E1 PLAN  
 1/4" = 1'-0"

PENDING AGENCY REVIEW - RELEASED FOR CONSTRUCTION